


County of Ventura
Initial Study
PL15-0106
Attachment 15 - Proposed Lighting Plan

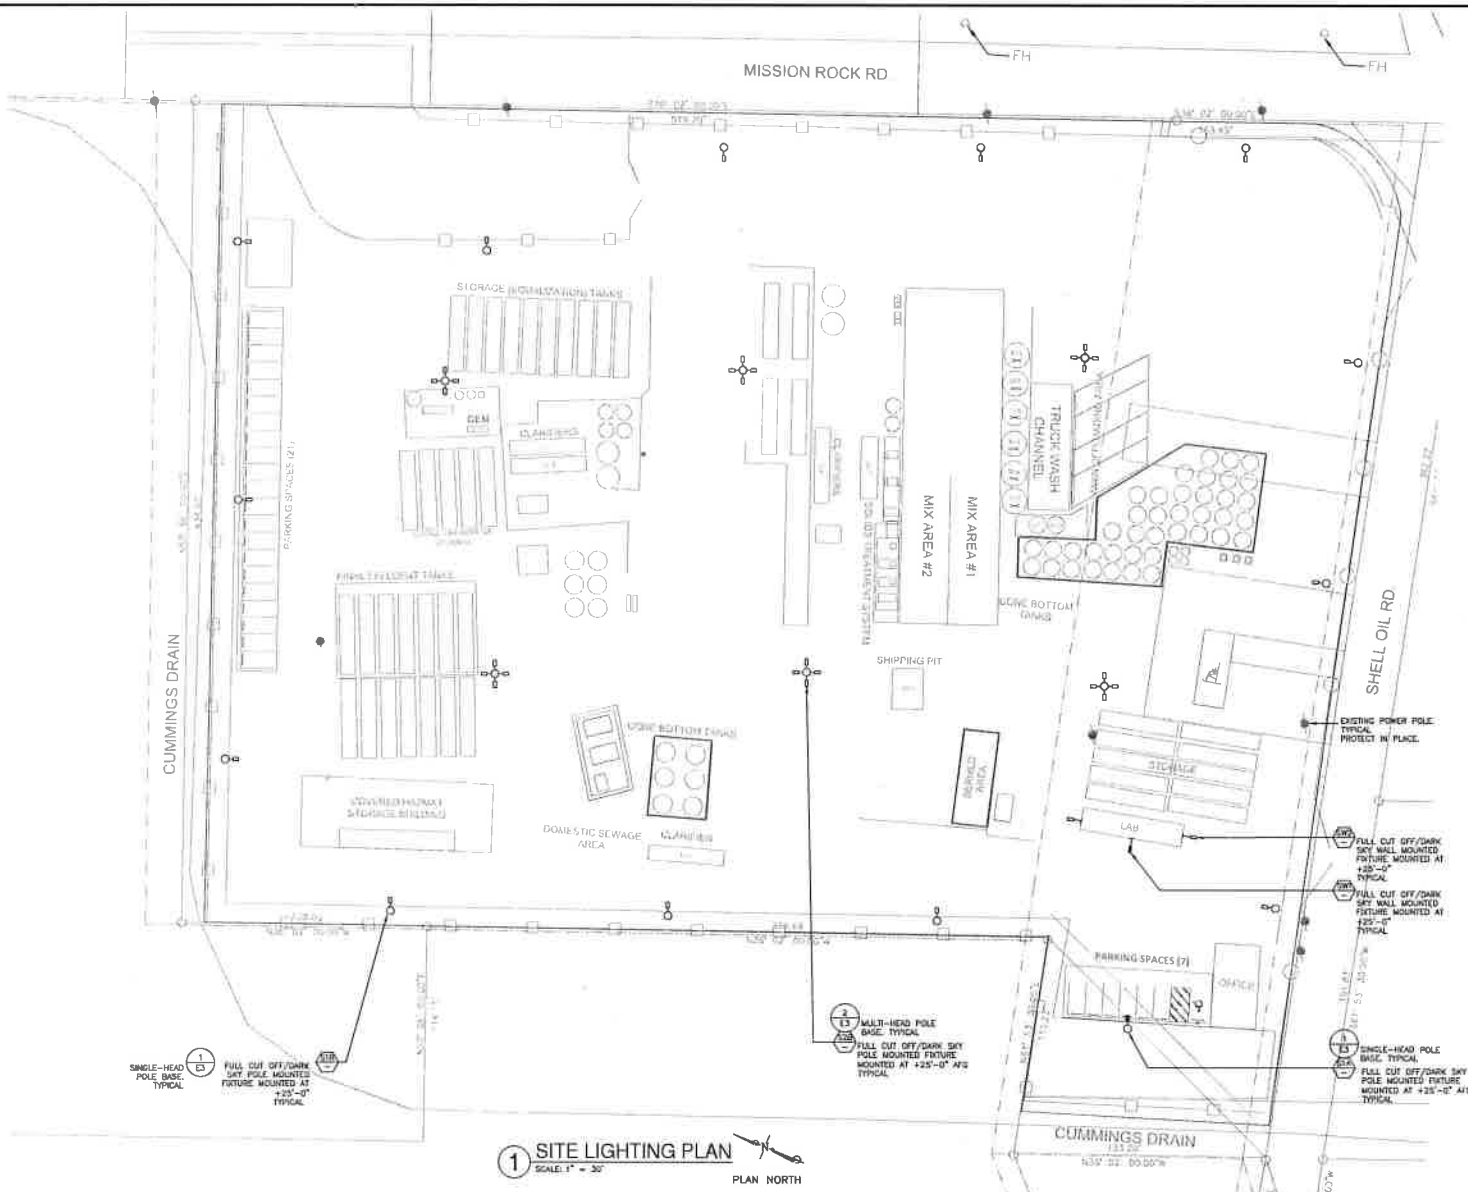


1 SITE LIGHTING PLAN
 SCALE: 1" = 30'
 PLAN NORTH

	C. HOOD ASSOCIATES, INC. CONSULTING ELECTRICAL ENGINEERS 850 East Front Street Ventura, California 93001 www.choodassociates.com Copyright © 2017	RASMUSSEN & ASSOCIATES Architects - Planning - Interiors 81 & California Street Fourth Floor Ventura, California 93001 800-666-1884	M-WW WASTE WATER TREATMENT FACILITY PROPOSED SITE PLAN SHEET NO. 2017 DATE: 08/28/2017
			SHEET NO. 2017 DATE: 08/28/2017 E1

DETAIL NOTES:

USE COMPRESSION LUGS TO TERMINATE CONDUCTORS TO LIGHT FIXTURES.

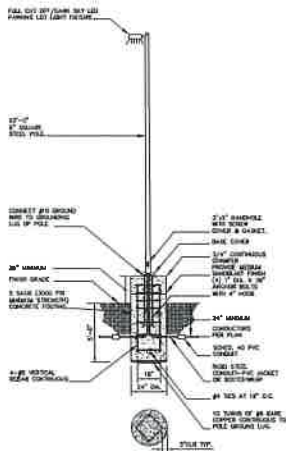


SINGLE HEAD TYPICAL PARKING LOT LIGHTING 24" CONCRETE BASE MOUNT DETAIL
SCALE: NONE

OUTDOOR LIGHTING FIXTURE SCHEDULE							
TAG	SYMBOL	QUANTITY	DESCRIPTION	LAMP - TYPE AND QUANTITY	HEIGHTS	MANUFACTURER AND MODEL NUMBER	REMARKS
130	○	130	LED SINGLE HEAD PARKING LOT LIGHT FIXTURE	LED 4000K	POLE HEIGHT	LITONIA 3807-LED-40C-180D-02C-170A-UVGLT	MOUNTED 25'-0" AFE
132	○	132	LED SINGLE HEAD PARKING LOT LIGHT FIXTURE	LED 4000K	POLE HEIGHT	LITONIA 3807-LED-40C-180D-02C-170A-UVGLT	MOUNTED 25'-0" AFE
134	○	134	LED QUAD HEAD PARKING LOT LIGHT FIXTURE	LED 4000K	POLE HEIGHT	LITONIA 3807-LED-40C-180D-02C-170A-UVGLT	MOUNTED 25'-0" AFE
457	○	457	EXTENDED LED SINGLE HEAD WALL MOUNT LIGHT FIXTURE	LED 4000K	HEIGHT 25'-0" AFE	LITONIA 3807-LED-40C-180D-02C-170A-UVGLT	MOUNTED 25' AFD ON BUILDING WALL
458	○	458	EXTENDED LED SINGLE HEAD WALL MOUNT LIGHT FIXTURE	LED 4000K	HEIGHT 25'-0" AFE	LITONIA 3807-LED-40C-180D-02C-170A-UVGLT	MOUNTED 25' AFD ON BUILDING WALL


- EXISTING SCHEDULE NOTES:**
- CONTRACTOR SHALL BE RESPONSIBLE FOR OBTAINING PROPER TYPES OF HOLES FOR ALL REQUIRED FIXTURES TO FIT THE EXISTING HOLES.
 - FIXTURE TYPE IN CONTACT WITH INSULATION SHALL HAVE ALL LISTED FEATURES.
 - CONTRACTOR SHALL VERIFY THE TYPE OF CEILING BEFORE ORDERING NEW FIXTURES. CONTRACTOR IS FULLY RESPONSIBLE TO PROVIDE ALL MOUNTING BRACKETS TO FIT CEILING CONDITIONS AT NO EXTRA CHARGE TO THE OWNER.
 - REFER TO ARCHITECTURAL REFLECTED CEILING PLAN FOR EXACT LOCATION OF LIGHTING FIXTURES.
 - SEE ARCHITECTURAL PLANS FOR EXACT DIMENSIONAL CEILING INFORMATION AND LIGHTING PLACEMENT.
 - FIXTURE TYPE QUANTITY (CHECK AND ADJUST QUANTITY IN LISTED FIXTURE TYPE IS TYPICAL FOR EXISTING HOLES)

DETAIL NOTES:

USE COMPRESSION LUGS TO TERMINATE CONDUCTORS TO LIGHT FIXTURES.

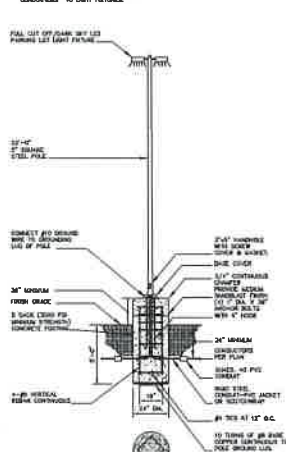

MULTI-HEAD TYPICAL PARKING LOT LIGHTING 24" CONCRETE BASE MOUNT DETAIL
SCALE: NONE

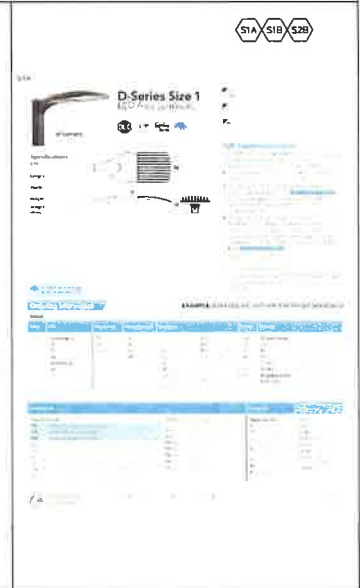

C. HOOD & ASSOCIATES, INC.
CONSULTING ELECTRICAL ENGINEERS
15302 EXP. 9-30-17
858 East Front Street Phone (805) 641-4013
Ventura, California 93001 Fax (805) 641-0450
www.choodandassociates.com
Copyright © 2017

RASMUSSEN & ASSOCIATES
Architects - Planners - Interiors
81 & Gallierola Street
Fourth Floor
Ventura, California 93001
DPO 848-1884

RI-NU WHITE WATER TREATMENT FACILITY
PROPOSED SITE PLAN
LIGHTING FIXTURE SCHEDULE AND ELECTRICAL DETAILS
E3
ri+nu
DATE: 04/23/2017